

DWARF FOUNTAIN GRASS (30 EA.)




HOLLYWOOD JUNIPER (5 EA.)


LIGHTING, LANDSCAPE & ACOUSTIC TREATMENT PLAN

SCALE: 1" = 20'

NOTE FIXTURES 'A' AND 'B' ARE PLUG IN MOUNTED UNDER UMBRELLAS AND AWNING

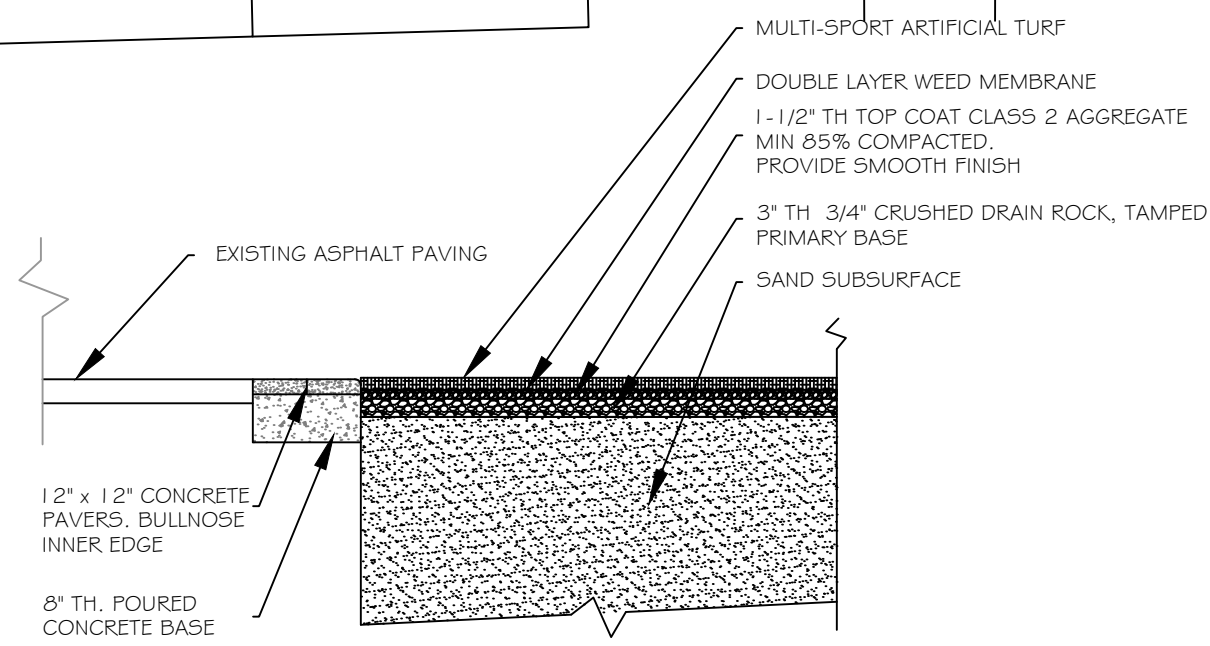


TURF AND EDGE DETAIL
3/8" = 1'

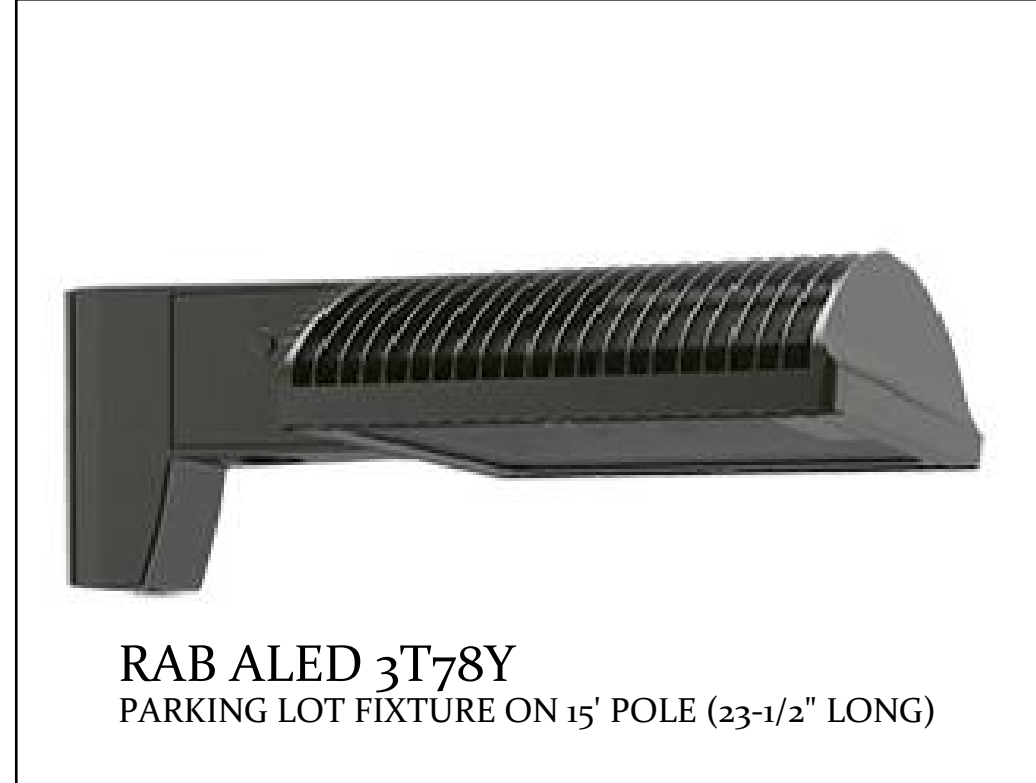

RAB ALED 3T78Y
PARKING LOT FIXTURE ON 15' POLE (23-1/2" LONG)

FIXTURE 'C'

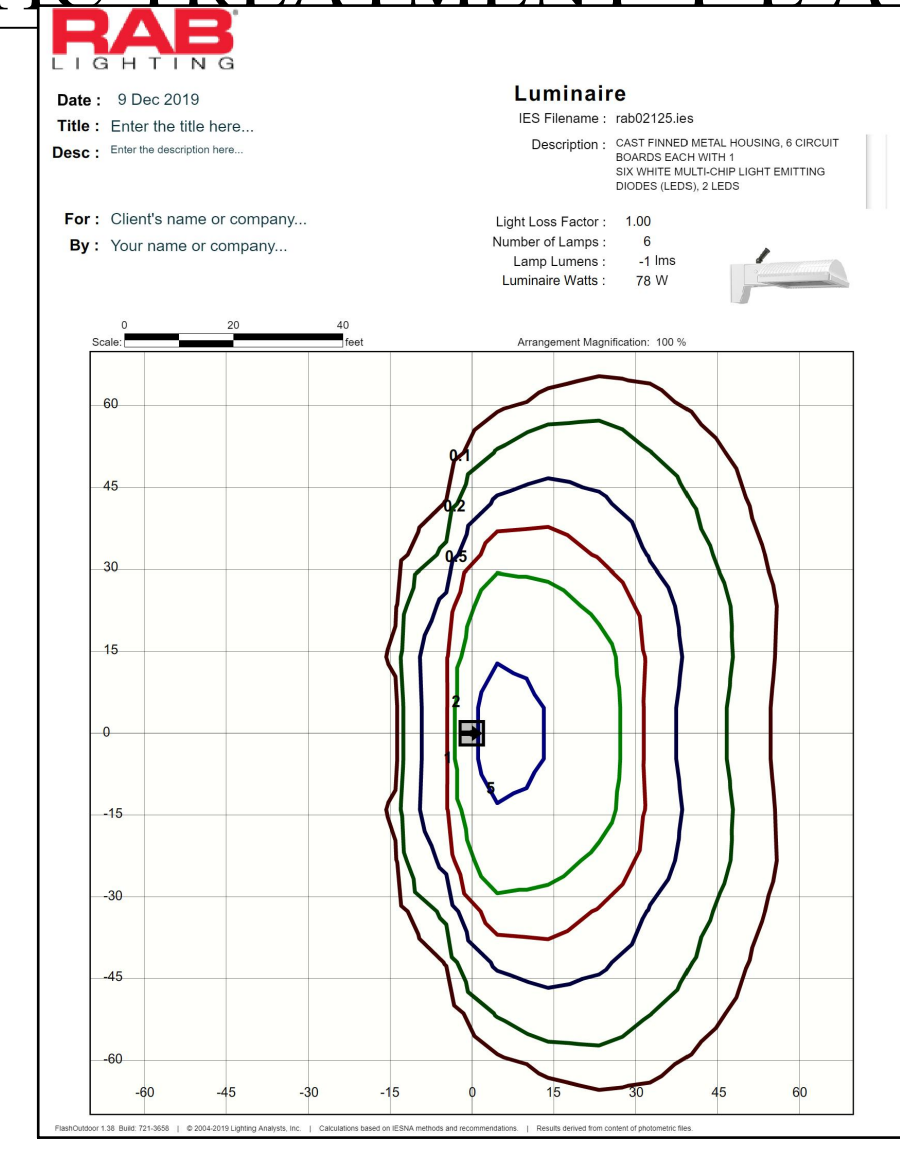

Shown in Satin Aluminum finish

FIXTURE 'D'



Shown in Cast Stainless Steel finish

FIXTURE 'E'

ISSUES / REVISIONS	m-USE Architects, PLLC 611 Broadway, Rm 721 New York, NY 10012 tel: 212.391.1580 e: ts@m-use.com	Robert I. Brown Architect, P.C. 205 Bay Ave. Greenport, NY info@ribrownarchitect.com 631-477-9752	CLIENT / OWNER	DRAWING TITLE	DRAWING No.
			CLAUDIO'S PWIB CLAUDIO'S MANAGEMENT 700 BROADWAY, NEW YORK, NY 10003	PROPOSED SITE LIGHTING PLAN	
			PROJECT	DATE	SCALE
			ADDITIONS & RENOVATIONS 111 MAIN STREET GREENPORT, NY 11944	REV JUNE 19, 2020	1" = 20'

IT IS A VIOLATION OF THE LAW FOR ANY PERSON, UNLESS ACTING UNDER THE DIRECTION OF A LICENSED ARCHITECT, TO ALTER ANY ITEM ON THIS DRAWING IN ANY WAY. ANY AUTHORIZED ALTERATION MUST BE NOTED, SEALED AND DISCUSSED IN ACCORDANCE WITH THE LAW.